


COURTHOUSE LIGHTING PLAN

SCALE 1:50

1 METRE

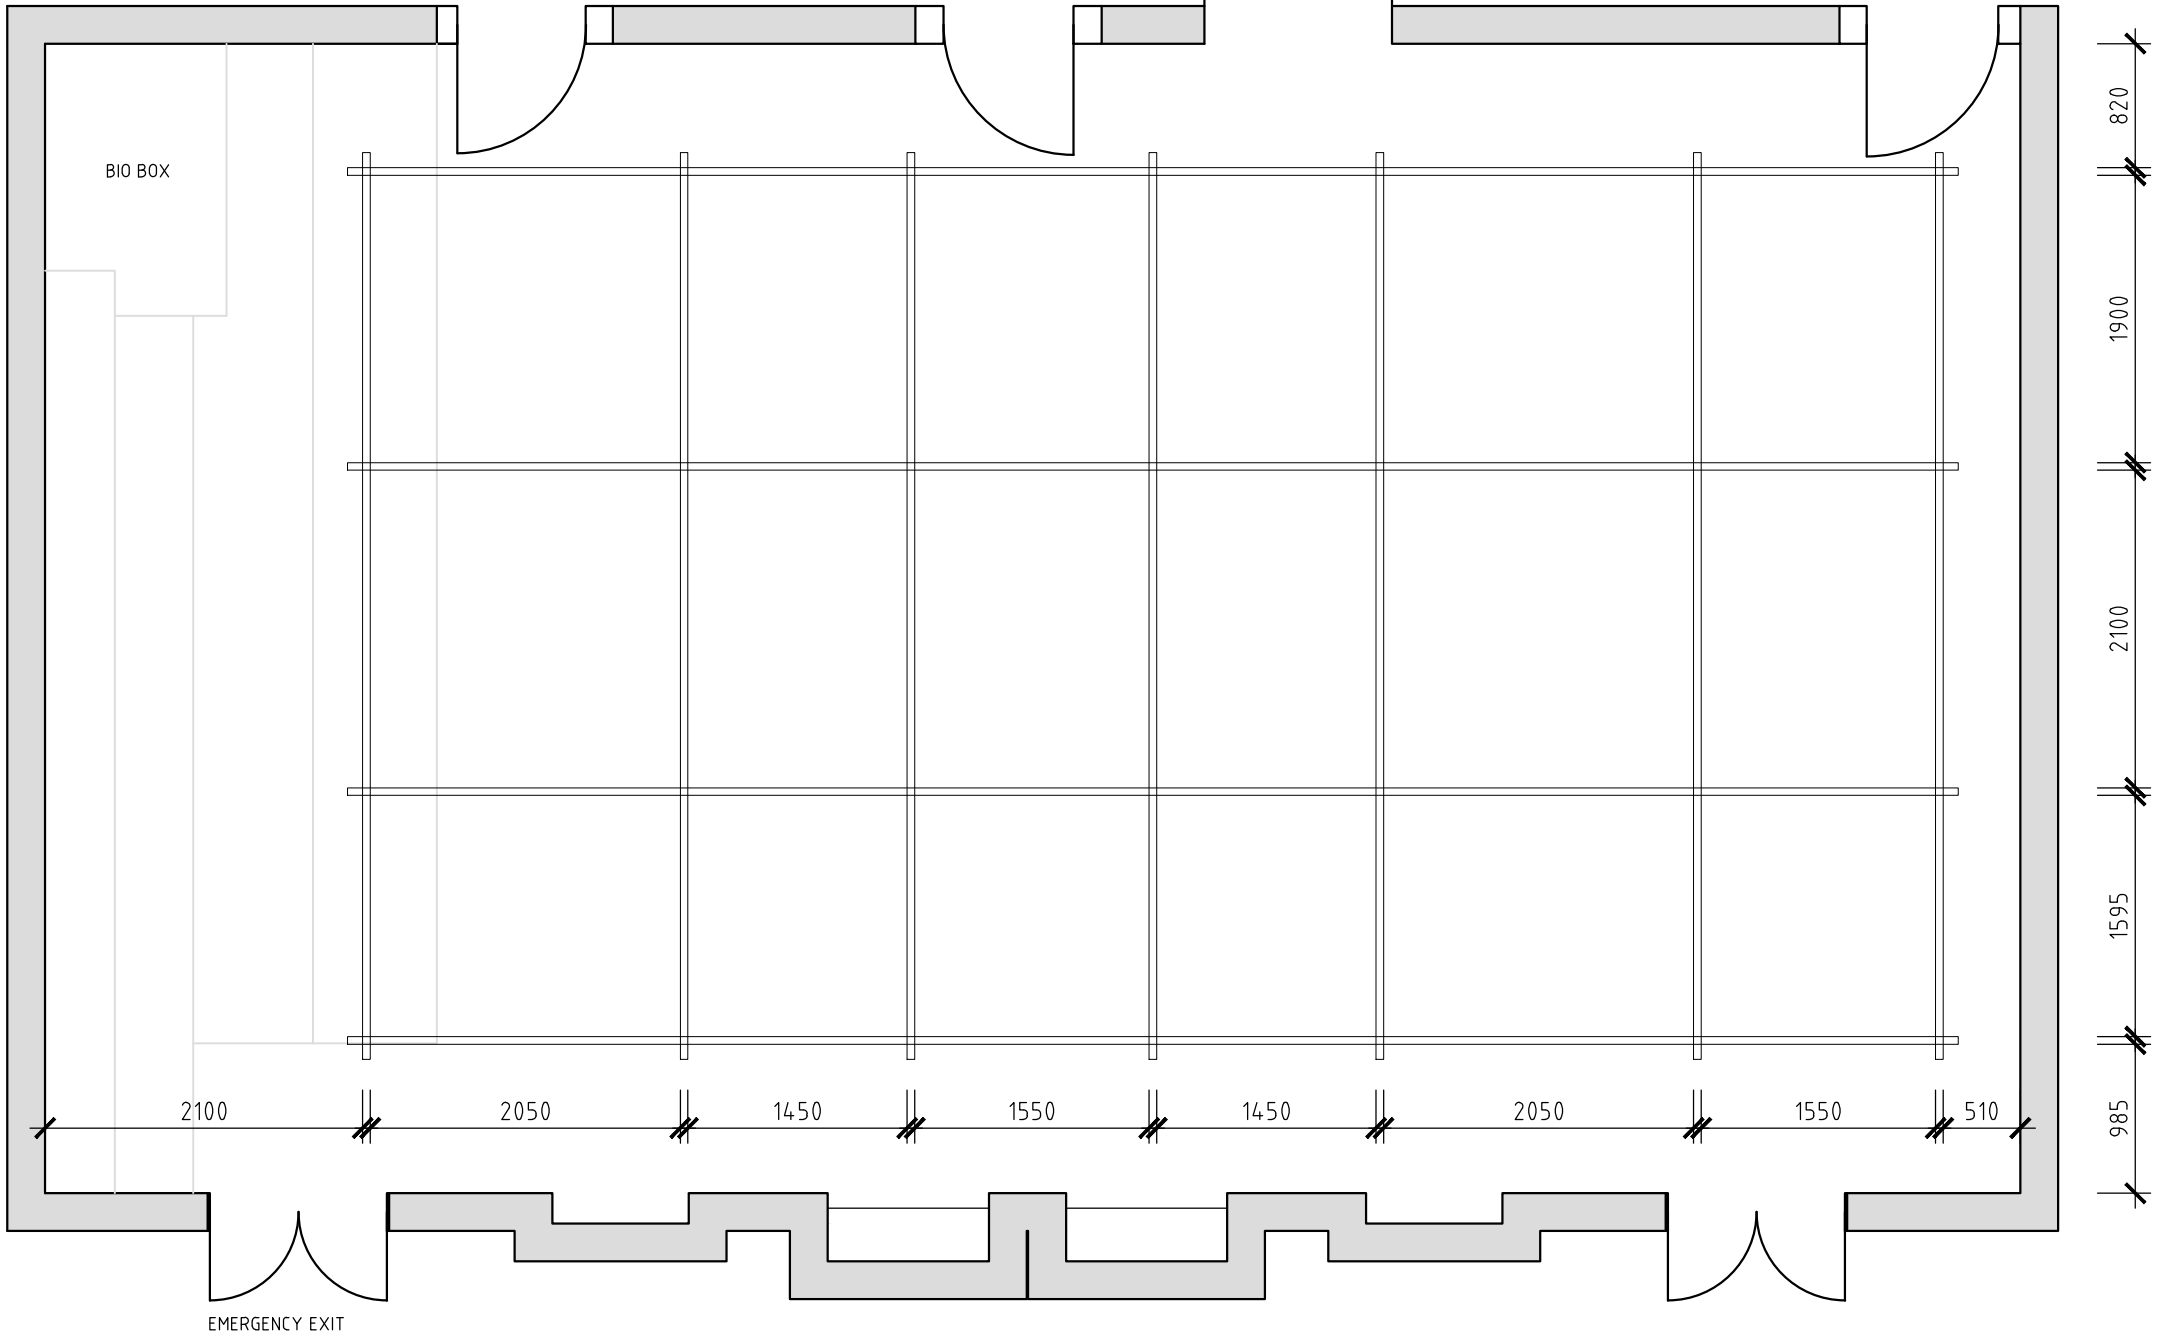

BIO BOX

DRESSING ROOM
EMERGENCY EXIT

TECH STORE

FOYER

FOYER

2100

2050

1450

1550

1450

2050

1550

510

820

1900

2100

1595

985

EMERGENCY EXIT